


F:\Dwg\0-2009-00BS\0919-Tnk-Msq\CD\Sketch\MEP\In\111211\ETRANSMIT\Z105(12-08-11).dwg, 5/22/2012 9:15:31 AM

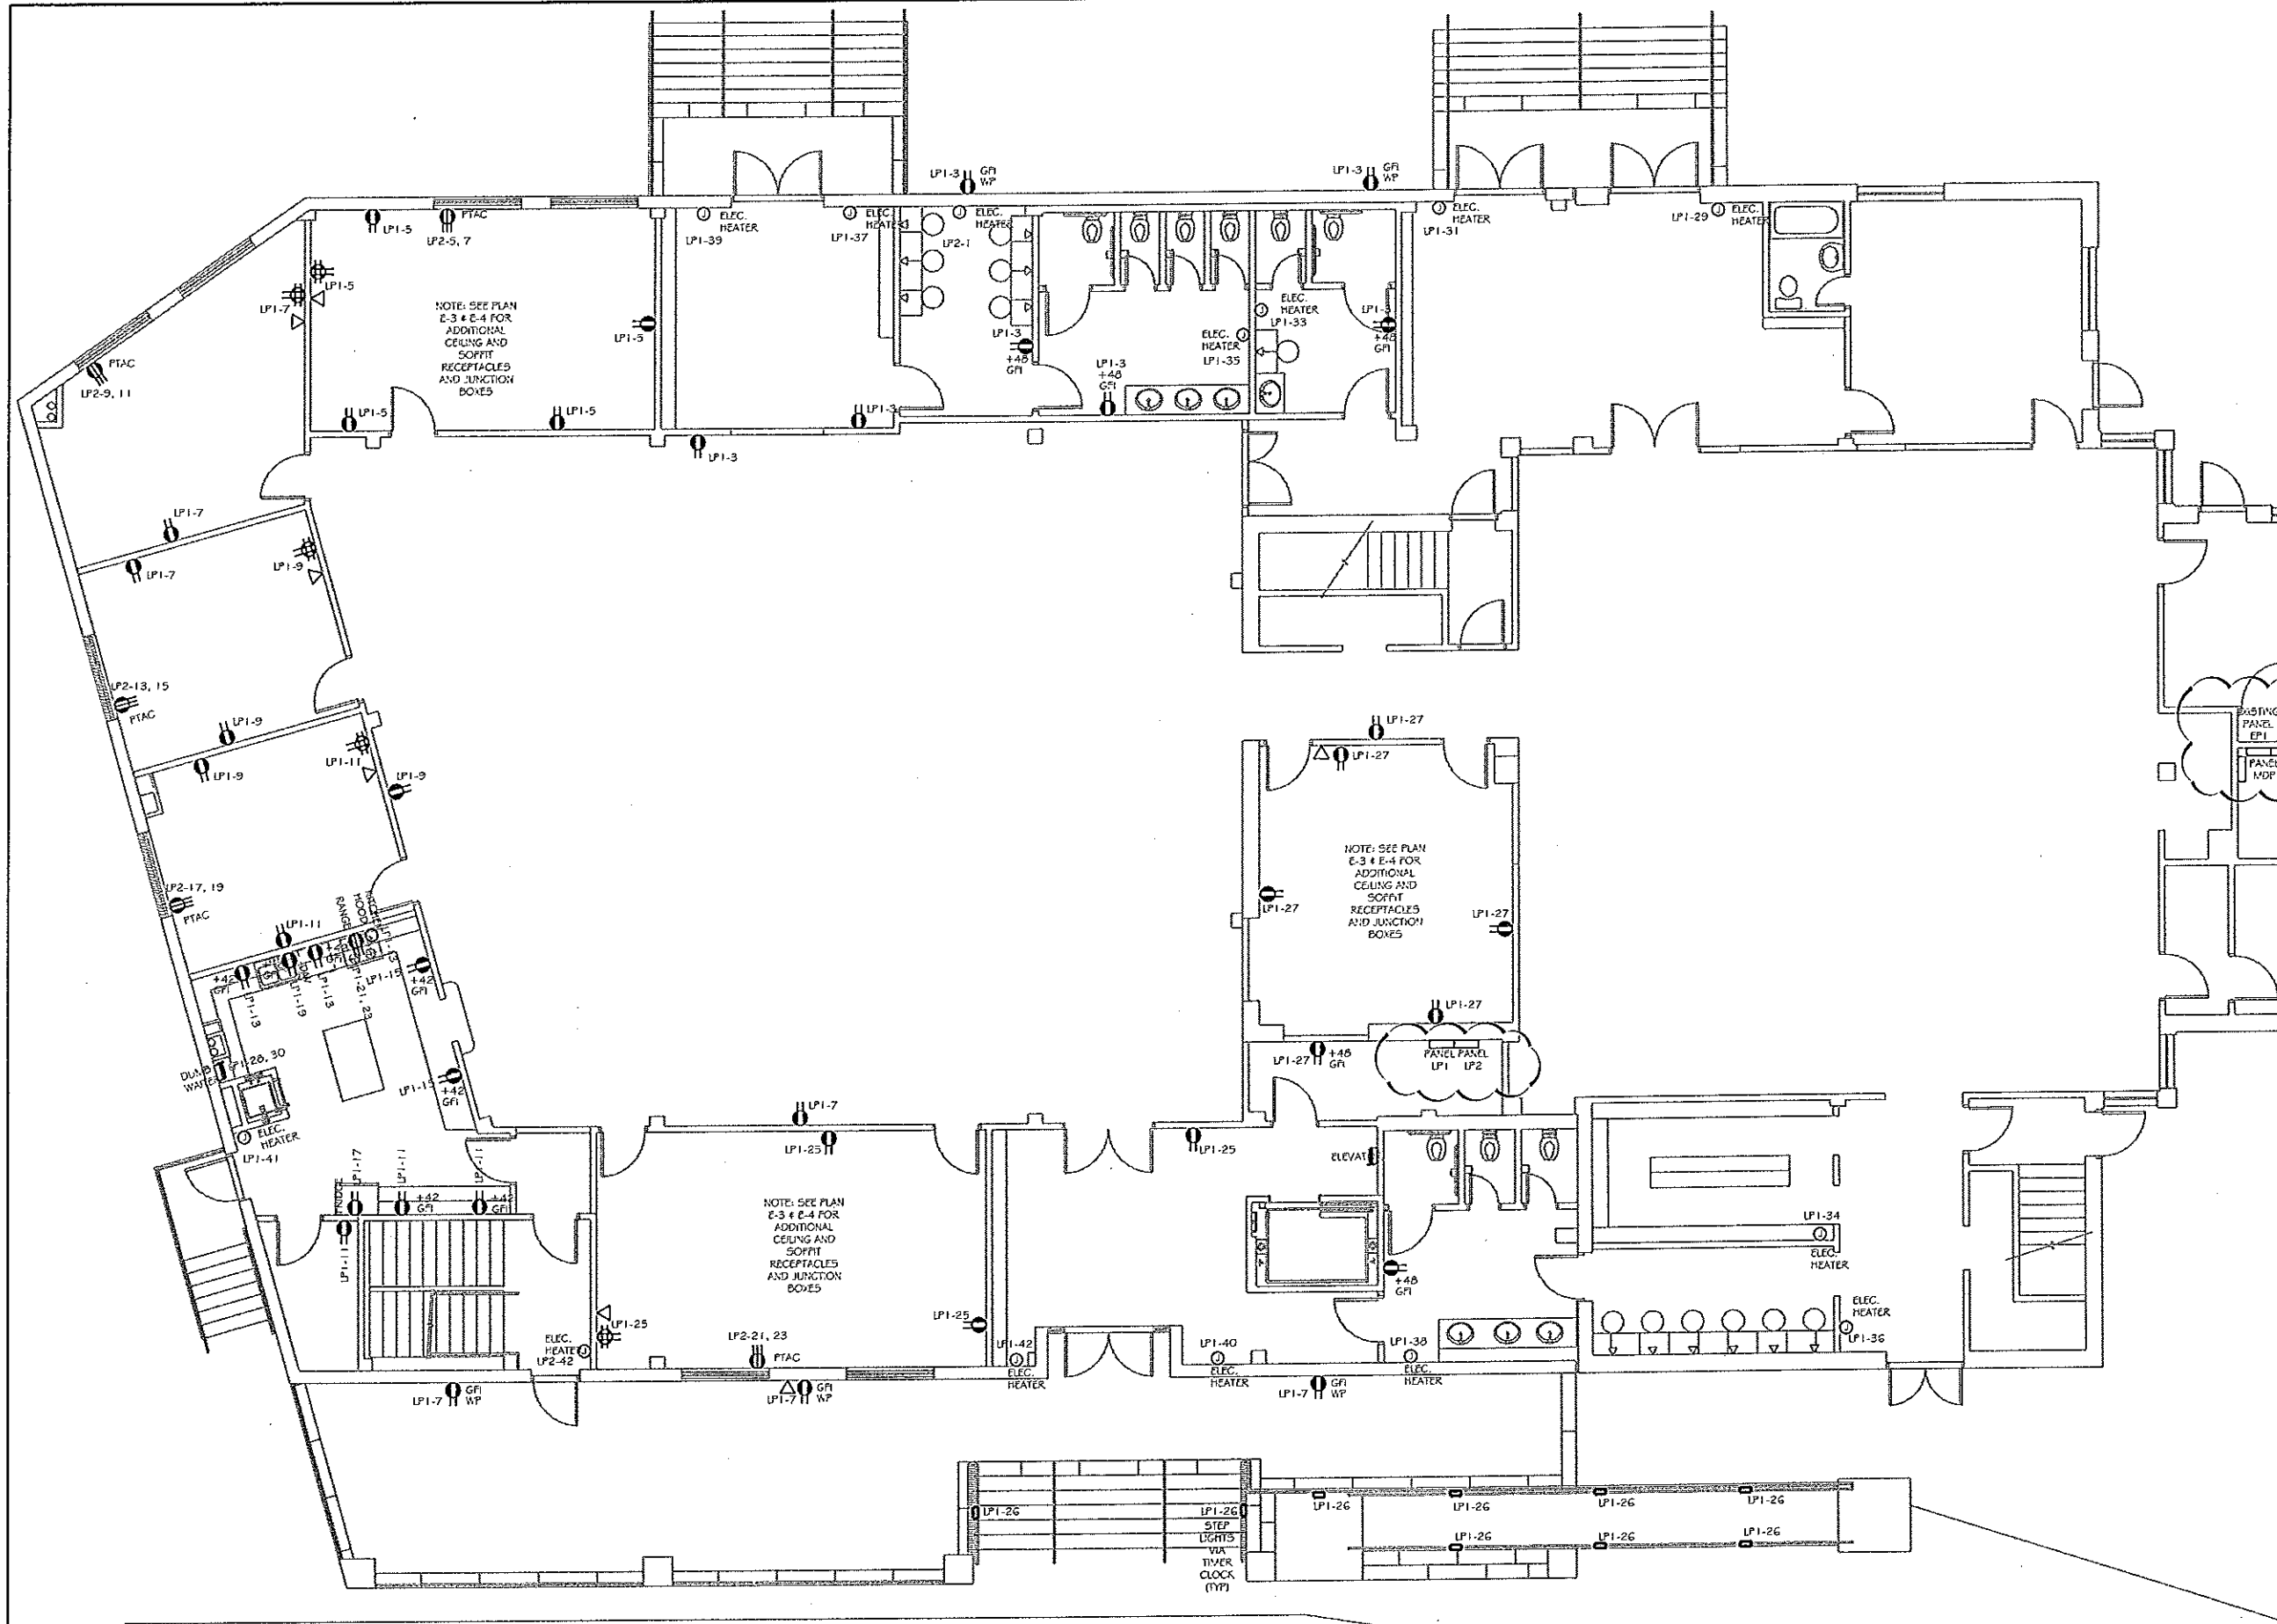

**ELECTRICAL LEGEND**

A-7	PANEL NAME AND CIRCUIT NUMBER
S1-S10	SWITCH DESIGNATION
WIRE	WIRE TO PANEL
WIRE	WIRE
TRIPLE WIRE	TRIPLE WIRE
PC	VIA PHOTOCELL
TC	VIA TIMER CLOCK
S	SWITCH
S	3 WAY SWITCH
R	DUPLICATE RECEPTACLE
R	GROUNDING DUPLICATE RECEPTACLE
R	GROUNDING QUADRUPLE RECEPTACLE
P	PHONE JACK
S	SMOKE DETECTOR
S	EMERGENCY SHUT OFF
WP	WEATHER PROOF
F	EXHAUST FAN
N	NITE LIGHT
BP	BATTERY PACK
GI	GROUND FAULT INTERRUPTER
RTU	ROOF TOP UNIT
MS	MOTION SENSOR
RH	RADIANT HEATER
LP1-2	PANEL DESIGNATION-CIRCUIT BREAKER DESIGNATION
EP	FUSED DISCONNECT

REV	DATE	REVISION
1	03-02-11	REVISE ELECTRIC HEATER BREAKERS
1	10-03-11	REVISE PANEL LOCATIONS TO COMBINE NEW & OLD SERVICE ENTRANCE
2	1-12-12	DWG. UPDATES

**Heritage Architecture, LLC**  
 Architecture Design Interiors  
 352 Empire St., Suite 2  
 Paramus, N.Y. 10765  
 Tel : (201) 262 3800  
 Fax : (201) 262 3802

Project No:	0919	Project:	DAR-UL ISLAM HOUSE OF WORSHIP (MOQUE)
Date:	December, 02, 2010	Drawn By:	YA
Checked By:	NA	Scale:	As Noted
Sheet:	E-1	Loc:	"
Block:	"	Block:	"

Sheet: Nassir Al-Mubtar, RA  
 NJ Lic. # 16036

Drawing No: **E-1**

© Heritage Architecture, LLC