


F:\Dwg\0-2009-JOBS\0919-Tnk-Msq\CD\Sketch\CD-As Built\consultant\MEP\In\111211\TRANSMIT\Z105\12-08-11).dwg, 5/22/2012 9:15:43 AM

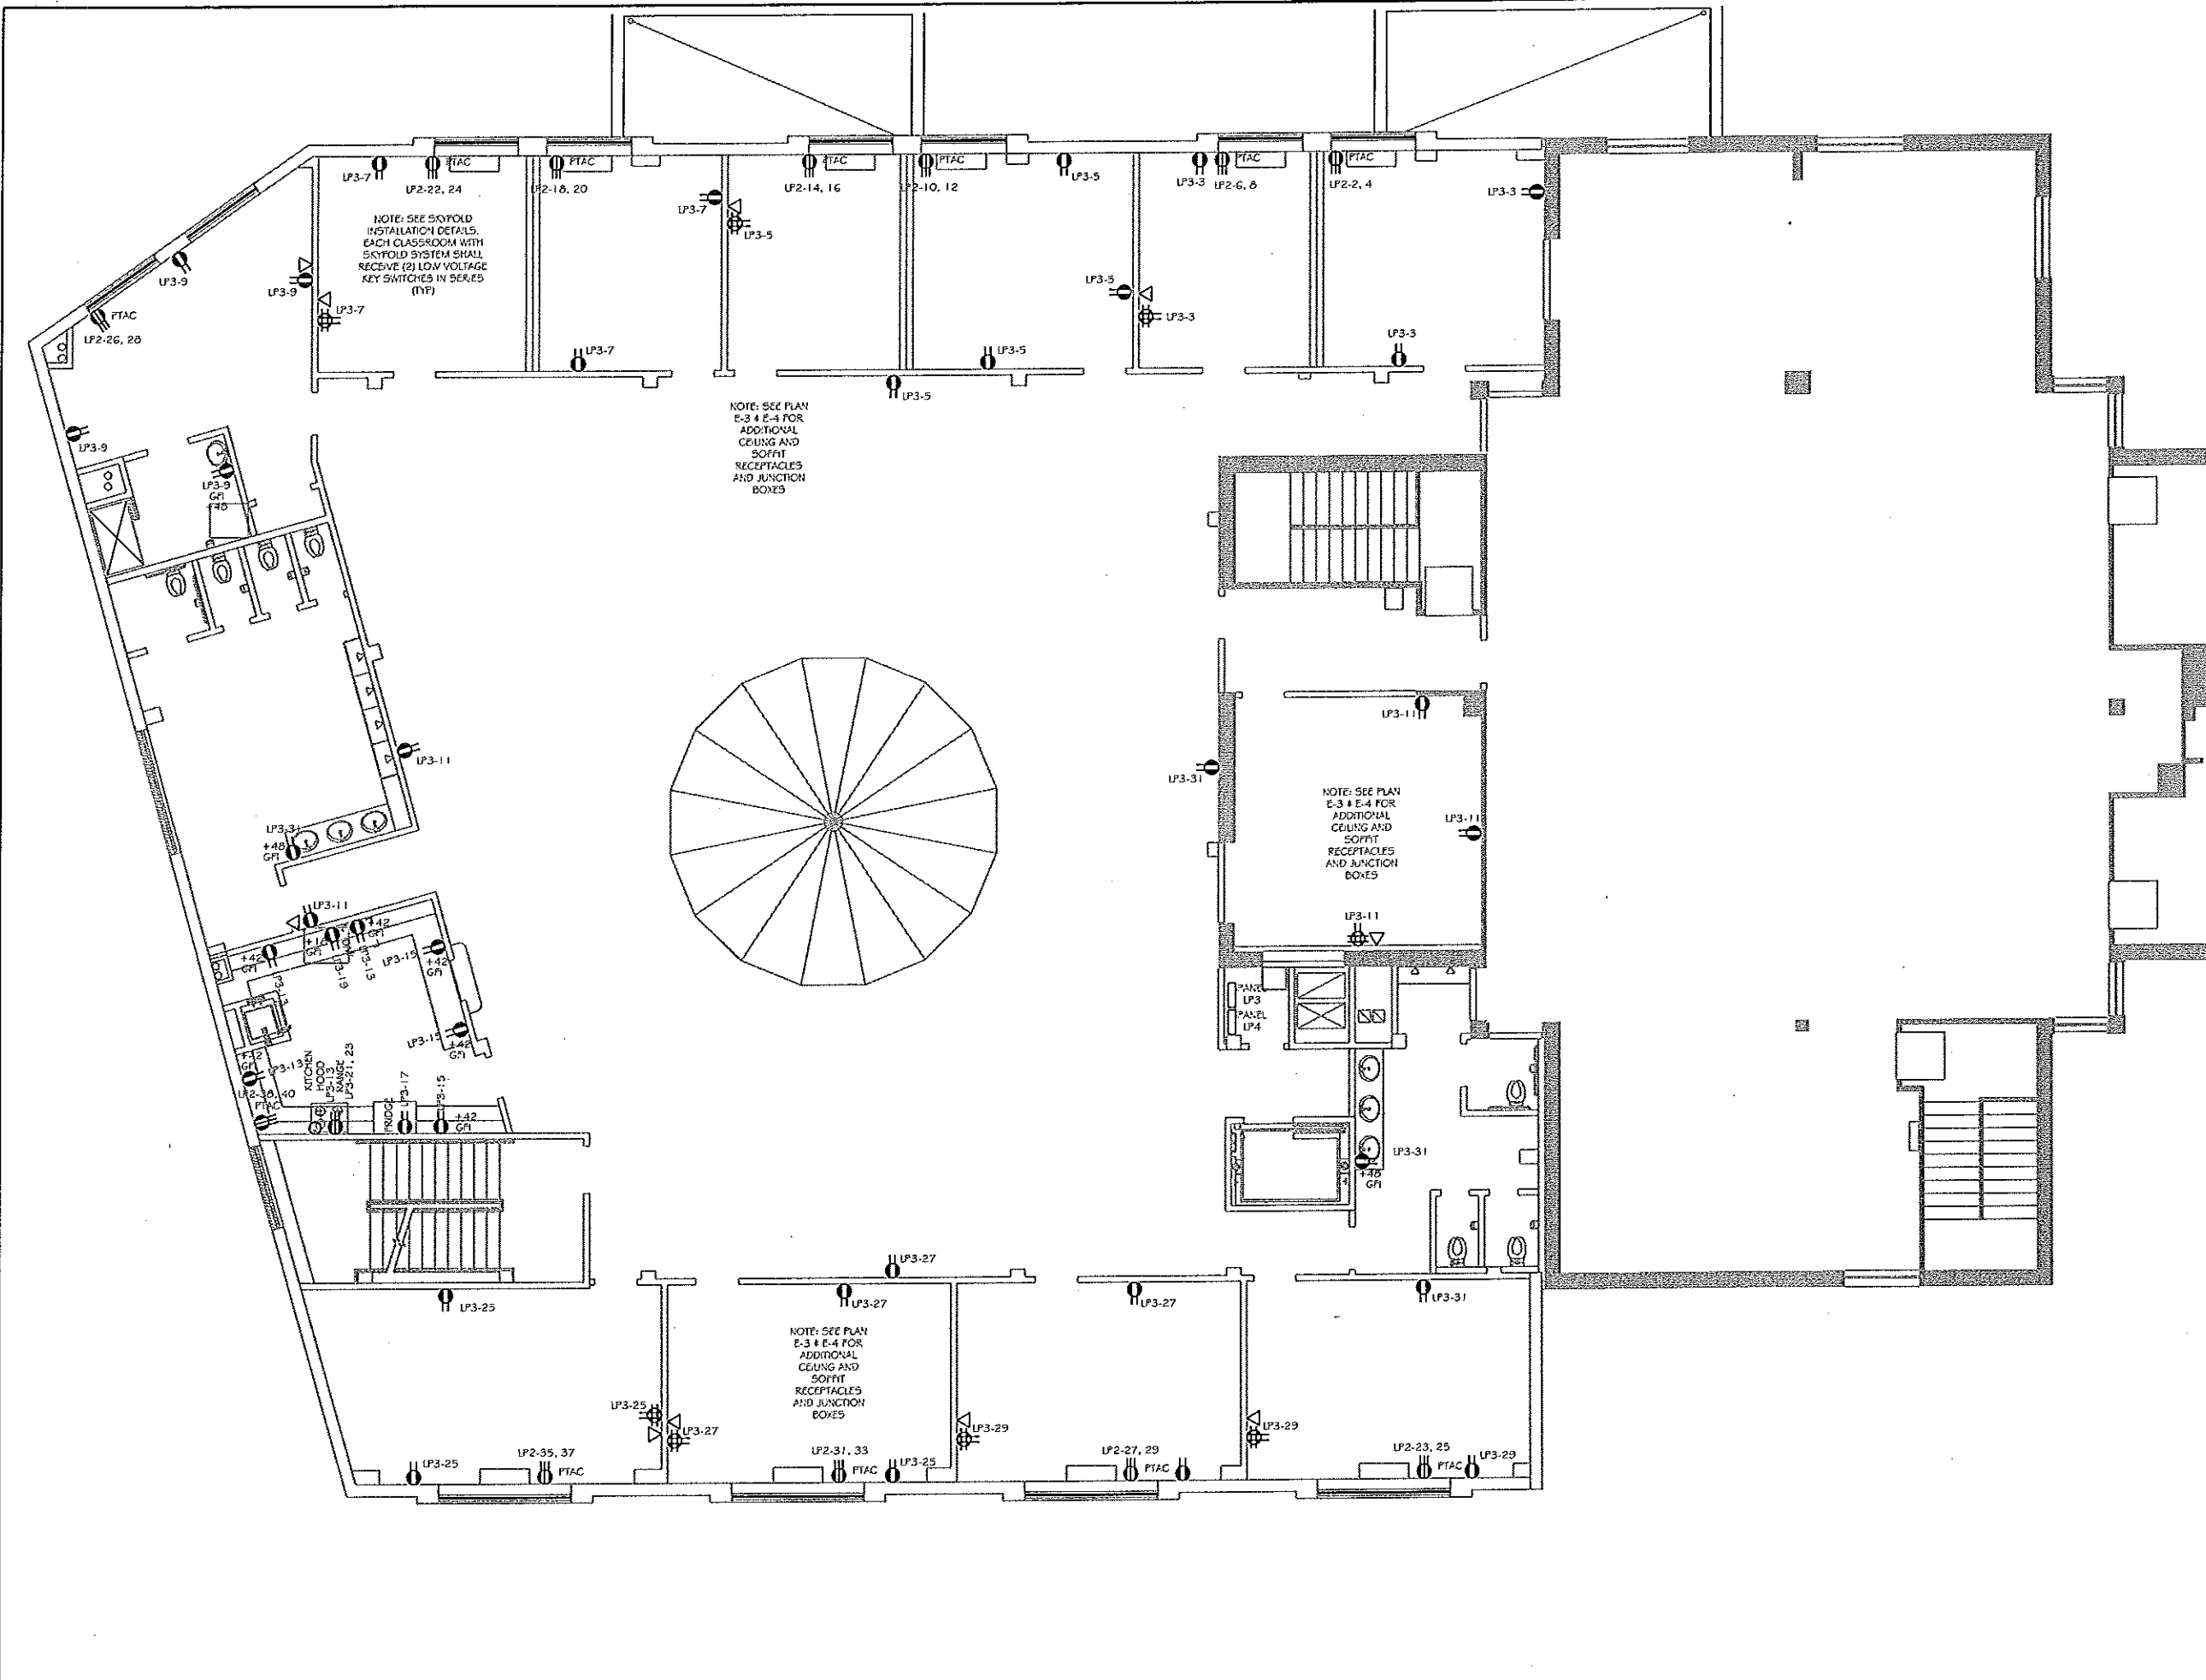

ELECTRICAL LEGEND

A-7	PANEL NAME AND CIRCUIT NUMBER
S-1	SWITCH DESIGNATION
WZ	WIRE TO PANEL
W	WIRE
3W	THREE WIRE
PC	VIA PHOTOCELL
TC	VIA TIMER CLOCK
S	SWITCH
S	3 WAY SWITCH
DP	DUPLEX RECEPTACLE
GR DP	GROUNDING DUPLEX RECEPTACLE
GR DP	GROUNDING DUPLEX RECEPTACLE
PH	PHONE JACK
SD	SMOKE DETECTOR
ES	EMERGENCY SHUT OFF
WP	WEATHER PROOF
DF	DRAUGHT FAN
NL	NITE LIGHT
BF	BATTERY BACK
GF	GROUND FAULT INTERRUPTER
RTU	ROOM TOP UNIT
VS	VISION SENSOR
RH	RADIANT HEATER
LP1-2	PANEL DESIGNATION, CIRCUIT BREAKER DESIGNATION
PSD	PUSH DISCONNECT

Rev	Date	Revision
2	1-12-12	DWG. UPDATES

Heritage Architecture, LLC
 Architecture Design Interiors
 252 Eagle St., Suite 2
 Paramus, N.Y. 07652
 Tel : (201) 261 3800
 Fax : (201) 261 3800

Project No:	0919	Project:	DAR-UL ISLAM HOUSE OF WORSHIP (ROSCOE)
Date:	December, 02, 2010	Drawn By:	YA
Checked By:	NA	Scale:	As Noted
Let:	"	Block:	"

2ND FLOOR ELECTRICAL POWER PLAN

Sheet: Nassir Ahmad, RA
 NJ Lic. # 16038

Drawing No: **E-2**
 © Heritage Architecture, LLC