


F:\Dwg\0-2009-JOBS\0919-Trk-Msq\CD\Sketch\CD-As Built\consultant\MEP\In\111211\ETRANSMIT\Z1051(12-08-11).dwg, 5/22/2012 9:15:52 AM

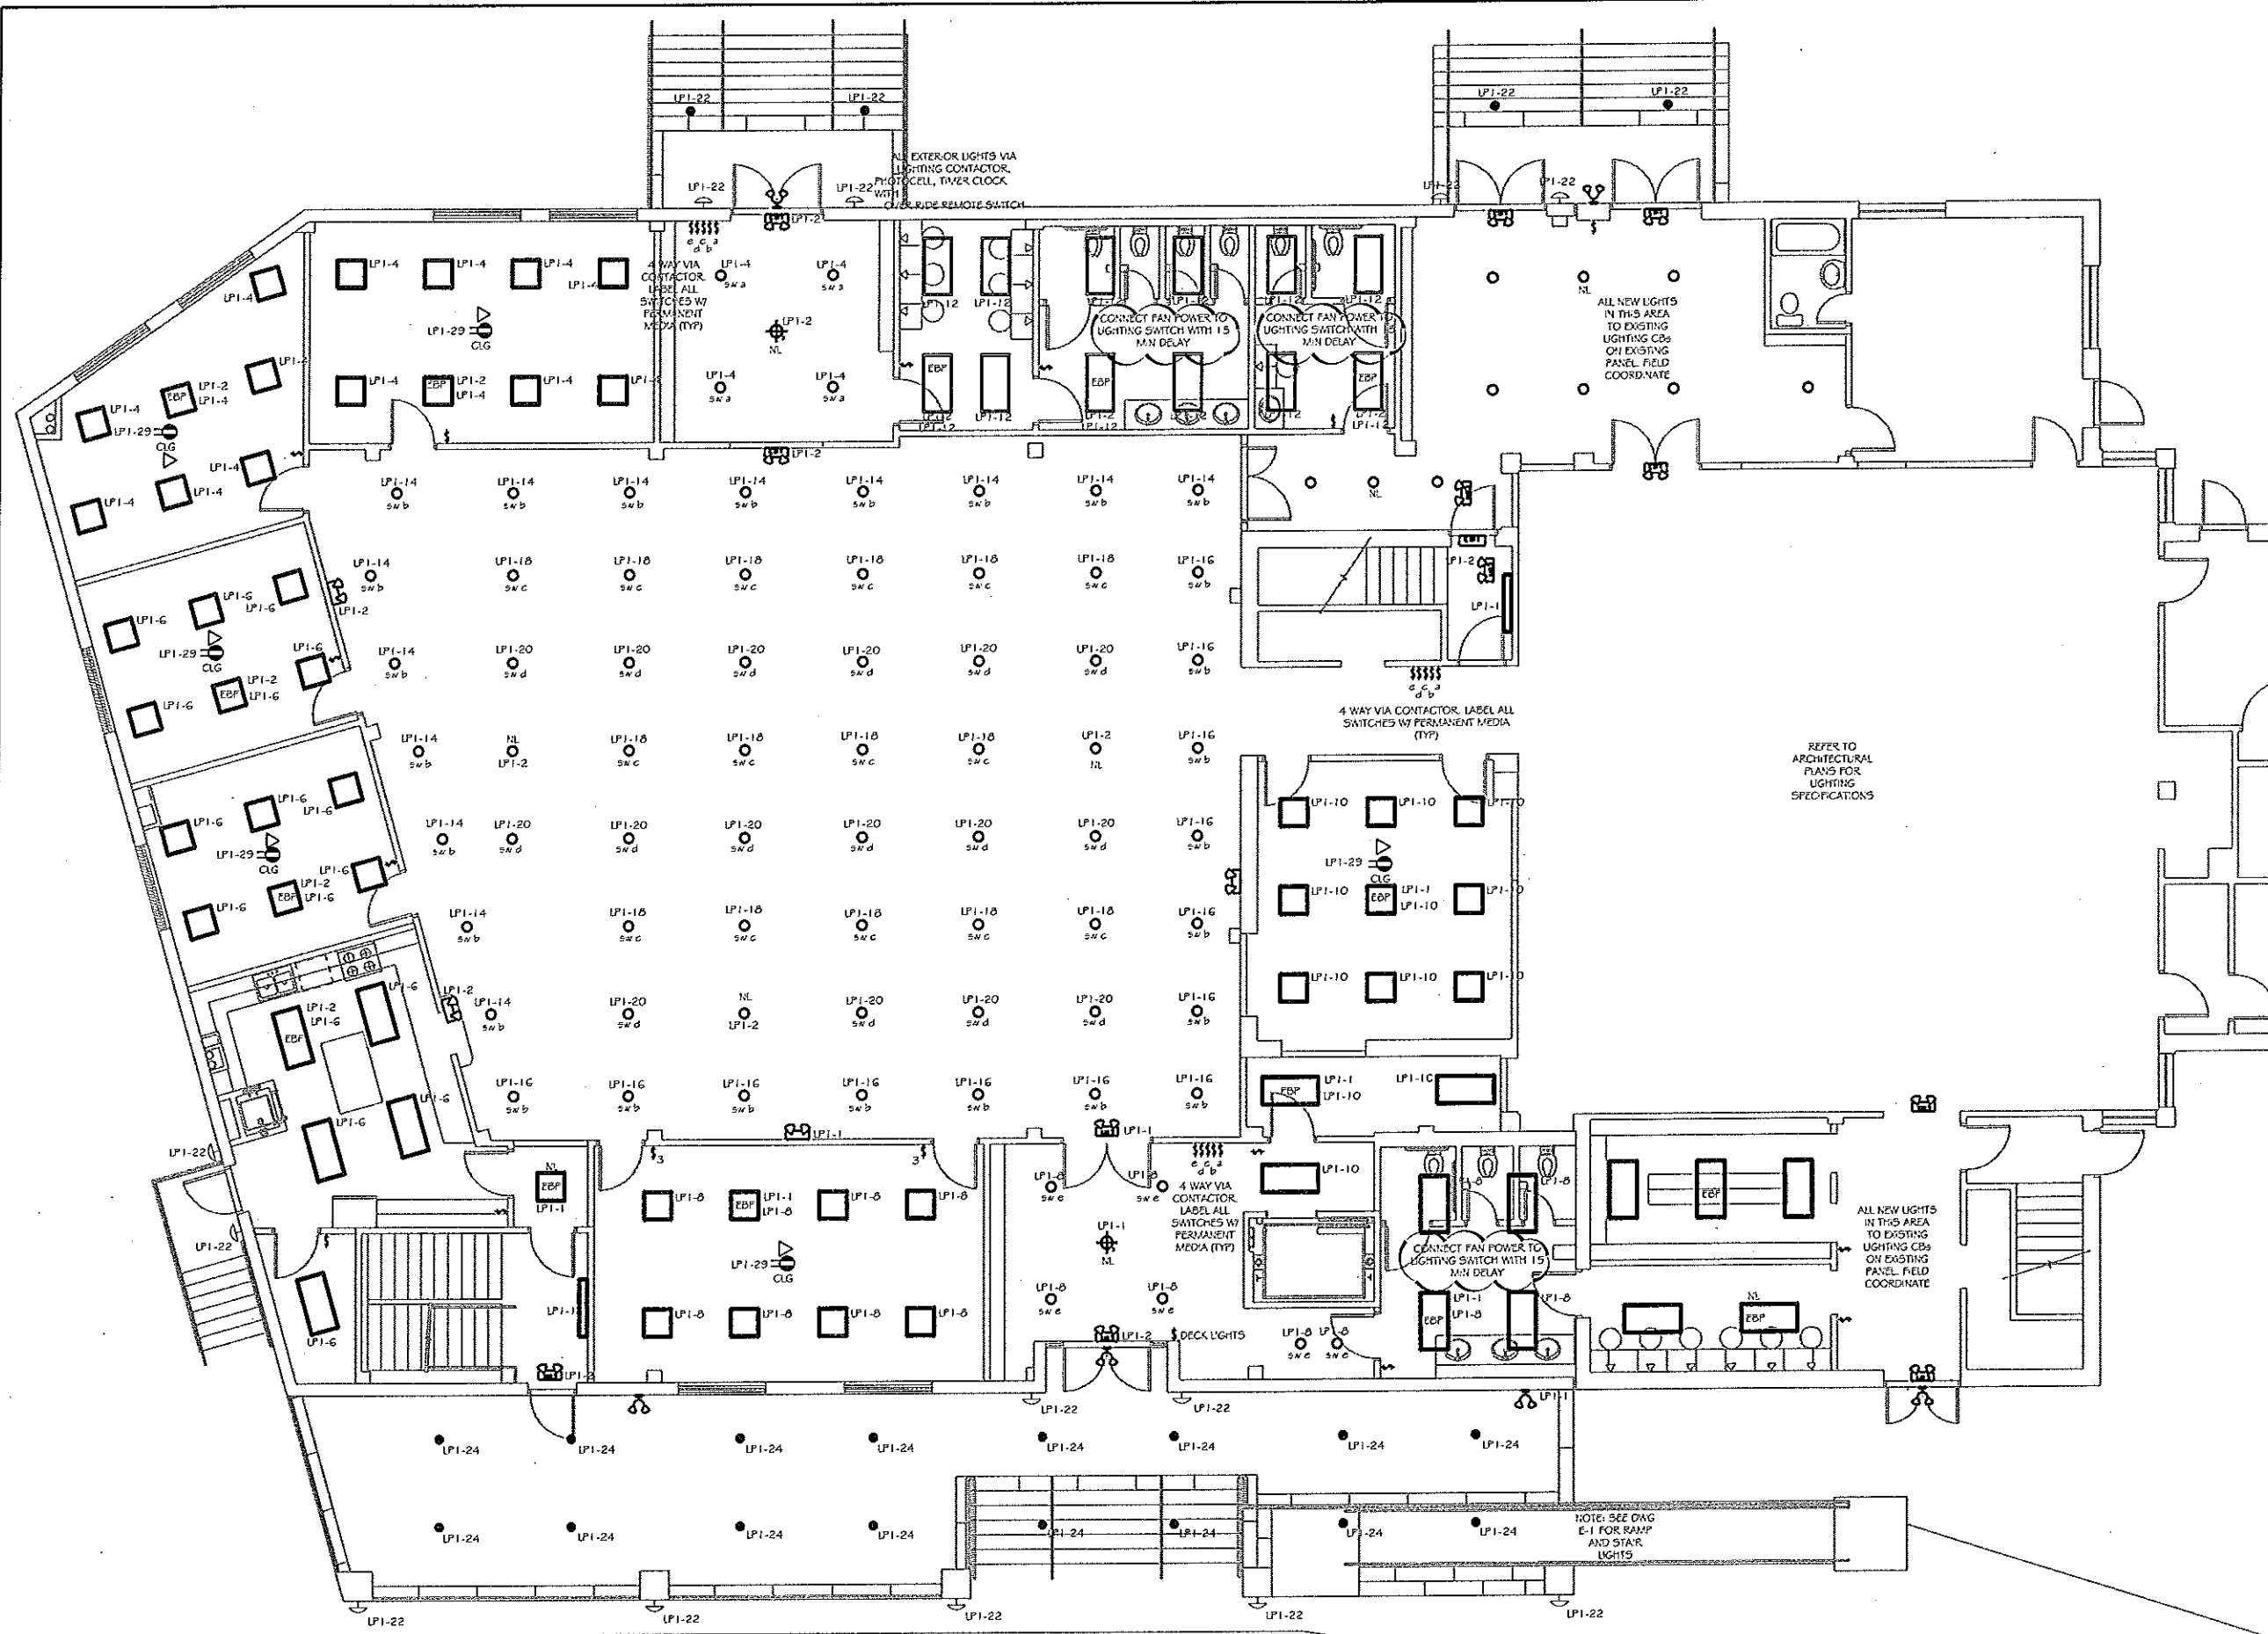

ELECTRICAL LEGEND

A-7	PANEL NAME AND CIRCUIT NUMBER
SW-2	SWITCH DESIGNATION
WFE	WIRE TO PANEL
WFE	WIRE
WFE	WIRE
FC	VIA PHOTOCELL
TC	VIA TIMER CLOCK
S	SWITCH
3-WAY	3-WAY SWITCH
DP	DUPLEX RECEPTACLE
GRD DP	GROUNDING DUPLEX RECEPTACLE
GRD QDR DP	GROUNDING QUADPLEX RECEPTACLE
PHJ	PHONE JACK
SD	SMOKE DETECTOR
ES-CR	EMERGENCY SWITCH CRP
WP	WEATHER PROOF
EF	EXHAUST FAN
NL	NITE LIGHT
BP	BATTERY PACK
GRF	GROUND FAULT INTERRUPTER
RTU	ROOF TOP UNIT
MS	MOTION SENSOR
RH	RADIANT HEATER
LP1-2	PANEL DESIGNATION - CIRCUIT BREAKER DESIGNATION
FUSED DISCONNECT	FUSED DISCONNECT

No.	Date	Revision
1	March 02, 2011	ADD NOTES
2	1-12-11	DWG. UPDATES

Heritage Architecture, LLC
 Architecture Design Interiors
 352 Euclid St., Suite 2
 Paramus, N.Y. 10765
 Tel : (201) 262 3000
 Fax : (201) 262 3002

Project No:	0919	Project:	DAR-UL ISLAM HOUSE OF WORSHIP (MOSQUE)
Date:	December 02, 2010	Drawn By:	YA
Checked By:	NA	Client:	
Scale:	As Noted	Drawing No.:	1ST FLOOR ELECTRICAL LIGHTING PLAN
Lot:	"		
Block:	"		

Sheet:
 Nassir Ahmadfar, RA
 NJ Lic. # 16038

Drawing No. **E-3**
 © Heritage Architecture, LLC