



F:\Dwg\0-2009-JOBS\0919-Trnk-Msq\CD\Sketch\CD-As Built\consultant\MEP\In\111211\ETRANSMIT\Z105(12-08-11).dwg, 5/22/2012 9:16:03 AM

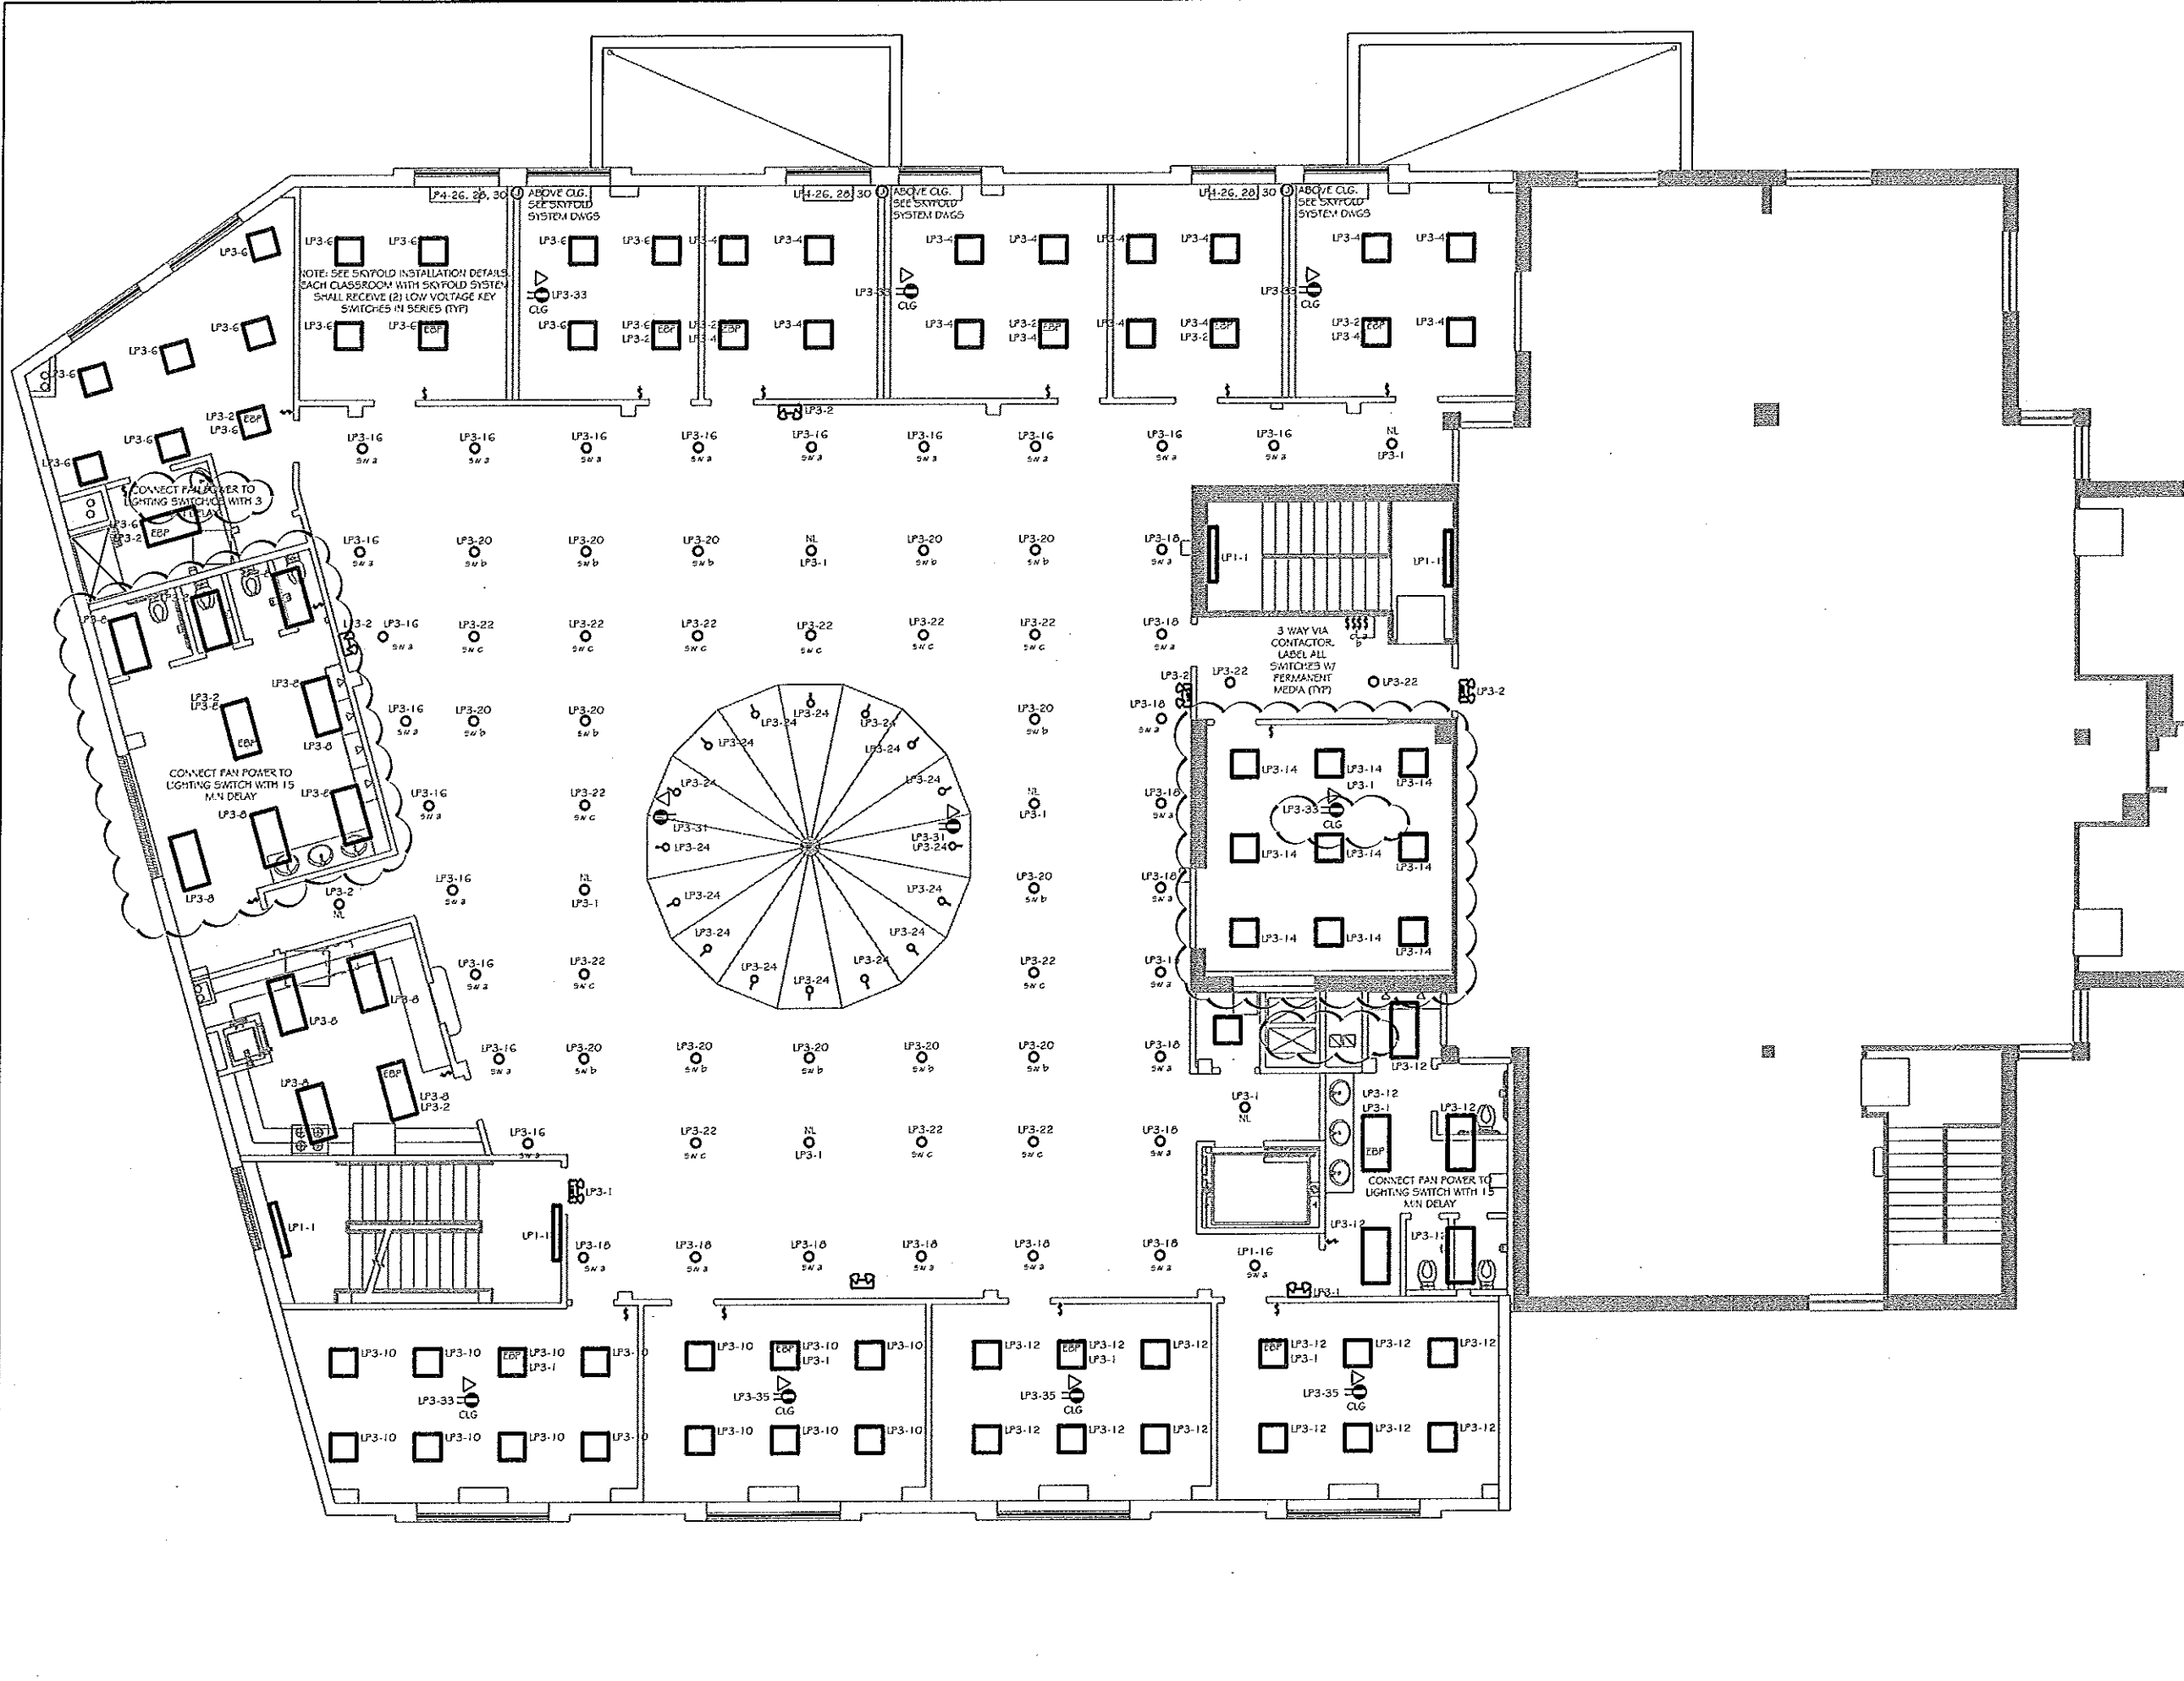

**ELECTRICAL LEGEND**

A-7	PANEL NAME AND CIRCUIT NUMBER
SW-1	SWITCH DESIGNATION
( )	WIRE TO PANEL
WFE	WIRE
THREE WIRE	THREE WIRE
PC	VIA PHOTOCELL
TC	VIA TIMER CLOCK
S	SWITCH
3-WAY SWITCH	3-WAY SWITCH
DUPLEX RECEPTACLE	DUPLEX RECEPTACLE
GROUNDING DUPLEX RECEPTACLE	GROUNDING DUPLEX RECEPTACLE
GROUNDING QUADPLEX RECEPTACLE	GROUNDING QUADPLEX RECEPTACLE
PHONE JACK	PHONE JACK
SMOKE DETECTOR	SMOKE DETECTOR
EMERGENCY SHUT OFF	EMERGENCY SHUT OFF
WP	WEATHER PROOF
EF	EXHAUST FAN
NL	NITE LIGHT
BATTERY PACK	BATTERY PACK
GF	GROUND FAULT INTERRUPTER
RTU	ROOF TOP UNIT
MS	MOTION SENSOR
RH	RADIANT HEATER
LP1-1	PANEL DESIGNATION, CIRCUIT BREAKER DESIGNATION
FUSED DISCONNECT	FUSED DISCONNECT

Rev	Date	Description
1	March 02, 2011	ADD FAN NOTES
2	1-12-11	DWG. UPDATES


**Heritage Architecture, LLC**  
 Architecture Design Interiors  
 352 Evelyn St., Suite 2  
 Paramus, N.Y. 07652  
 Tel : (201) 262 3000  
 Fax : (201) 262 3002

Project No:	0919	Project:	DAR-UL ISLAM HOUSE OF WORSHIP (MOSQUE)
Date:	December, 02, 2010	Drawn By:	YA
Checked By:	NA	Client:	203 Fabry Terrace, Teaneck, New Jersey 07626
Scale:	As Noted	Drawing Title:	<b>2ND FLOOR ELECTRICAL LIGHTING PLAN</b>
Lot:	"		
Block:	"		
Seat:	Nasser Alshabbar, RA NJ Lic. # 16036	Drawing No.:	<b>E-4</b>

© Heritage Architecture, LLC