



F:\Dwg\0-2009-JOBS\0919-Trnk-Msq\CD\Sketch\CD-As Buil\consultant\MEP\m\111211\ETRANSMIT\Z105\12-08-11.dwg, 5/22/2012 9:16:15 AM

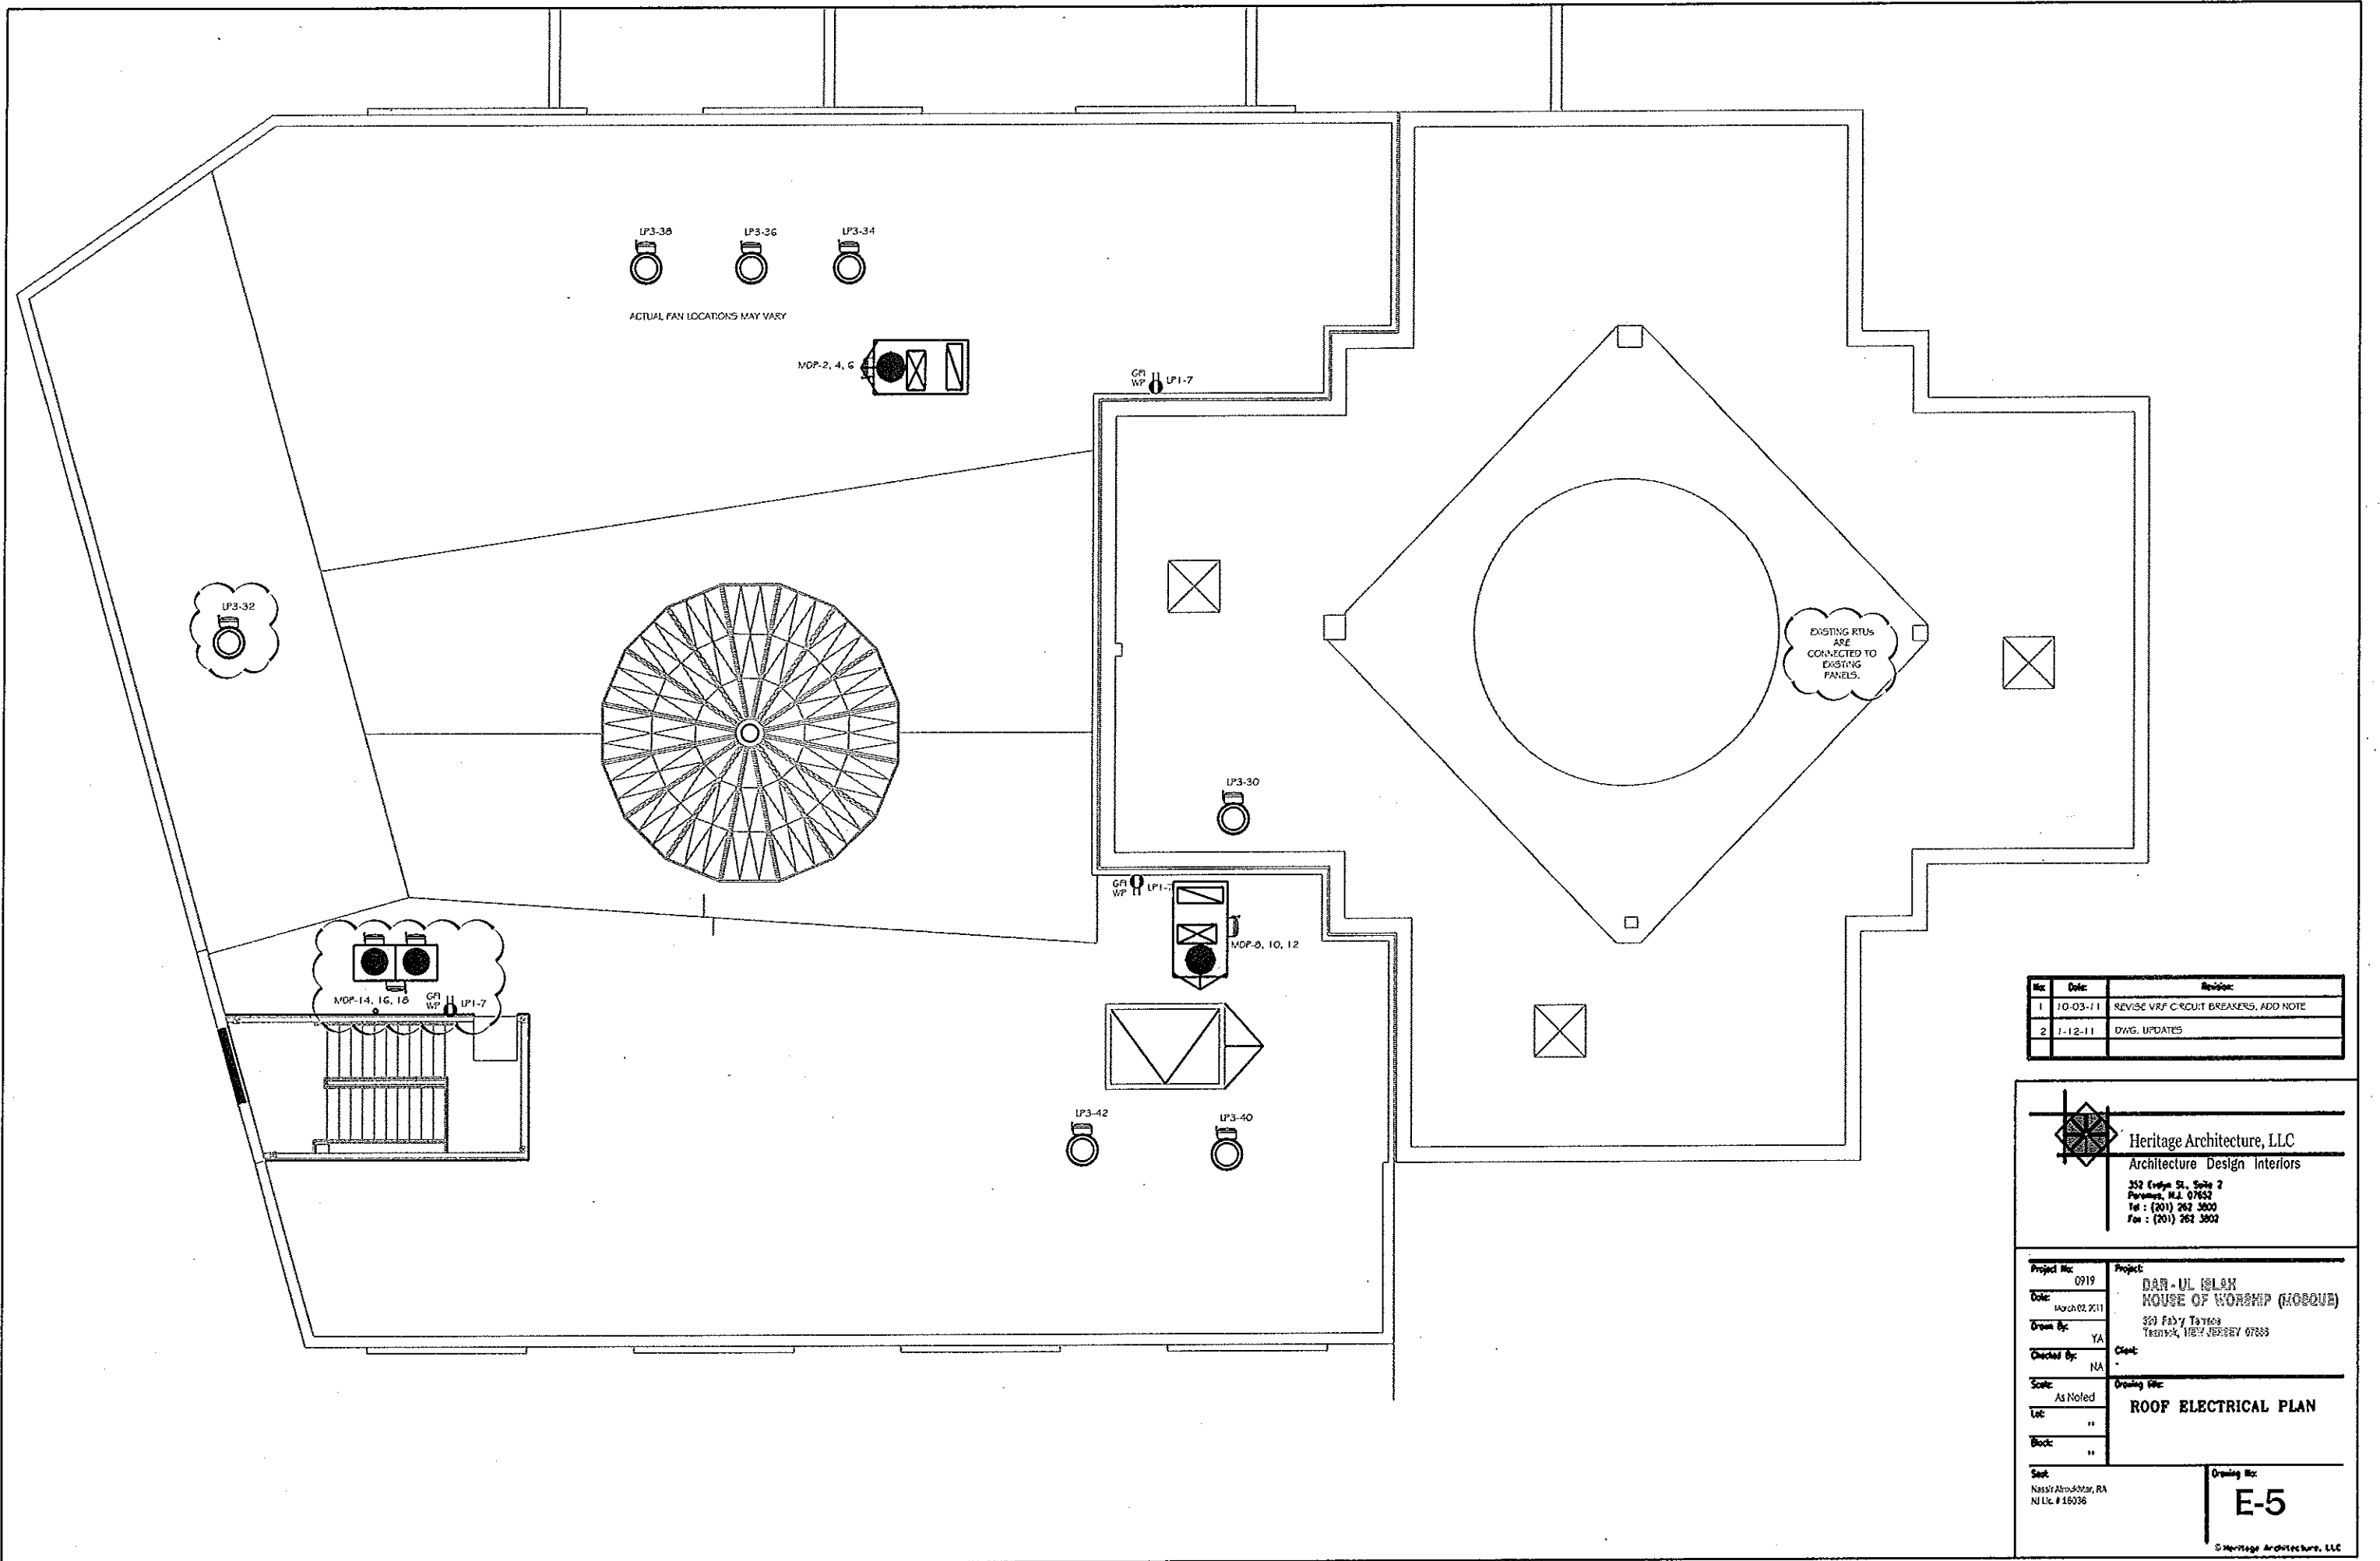

Rev	Date	Revision
1	10-03-11	REVISE VRF C-CIRCUIT BREAKERS, ADD NOTE
2	1-12-11	DWG. UPDATES


Heritage Architecture, LLC
 Architecture Design Interiors
 352 Evelyn St., Suite 2
 Paramus, N.J. 07652
 Tel : (201) 262 3000
 Fax : (201) 262 3002

Project No: 0919	Project: DAR - UL ISLAM HOUSE OF WORSHIP (MOSQUE)
Date: March 02, 2011	Drawn By: YA
Checked By: NA	Client:
Scale: As Noted	Drawing Title: ROOF ELECTRICAL PLAN
Lot: "	
Block: "	

Seal: Nassir Alroshdar, RA
 NJ Lic. # 18036

Drawing No:
E-5

© Heritage Architecture, LLC